



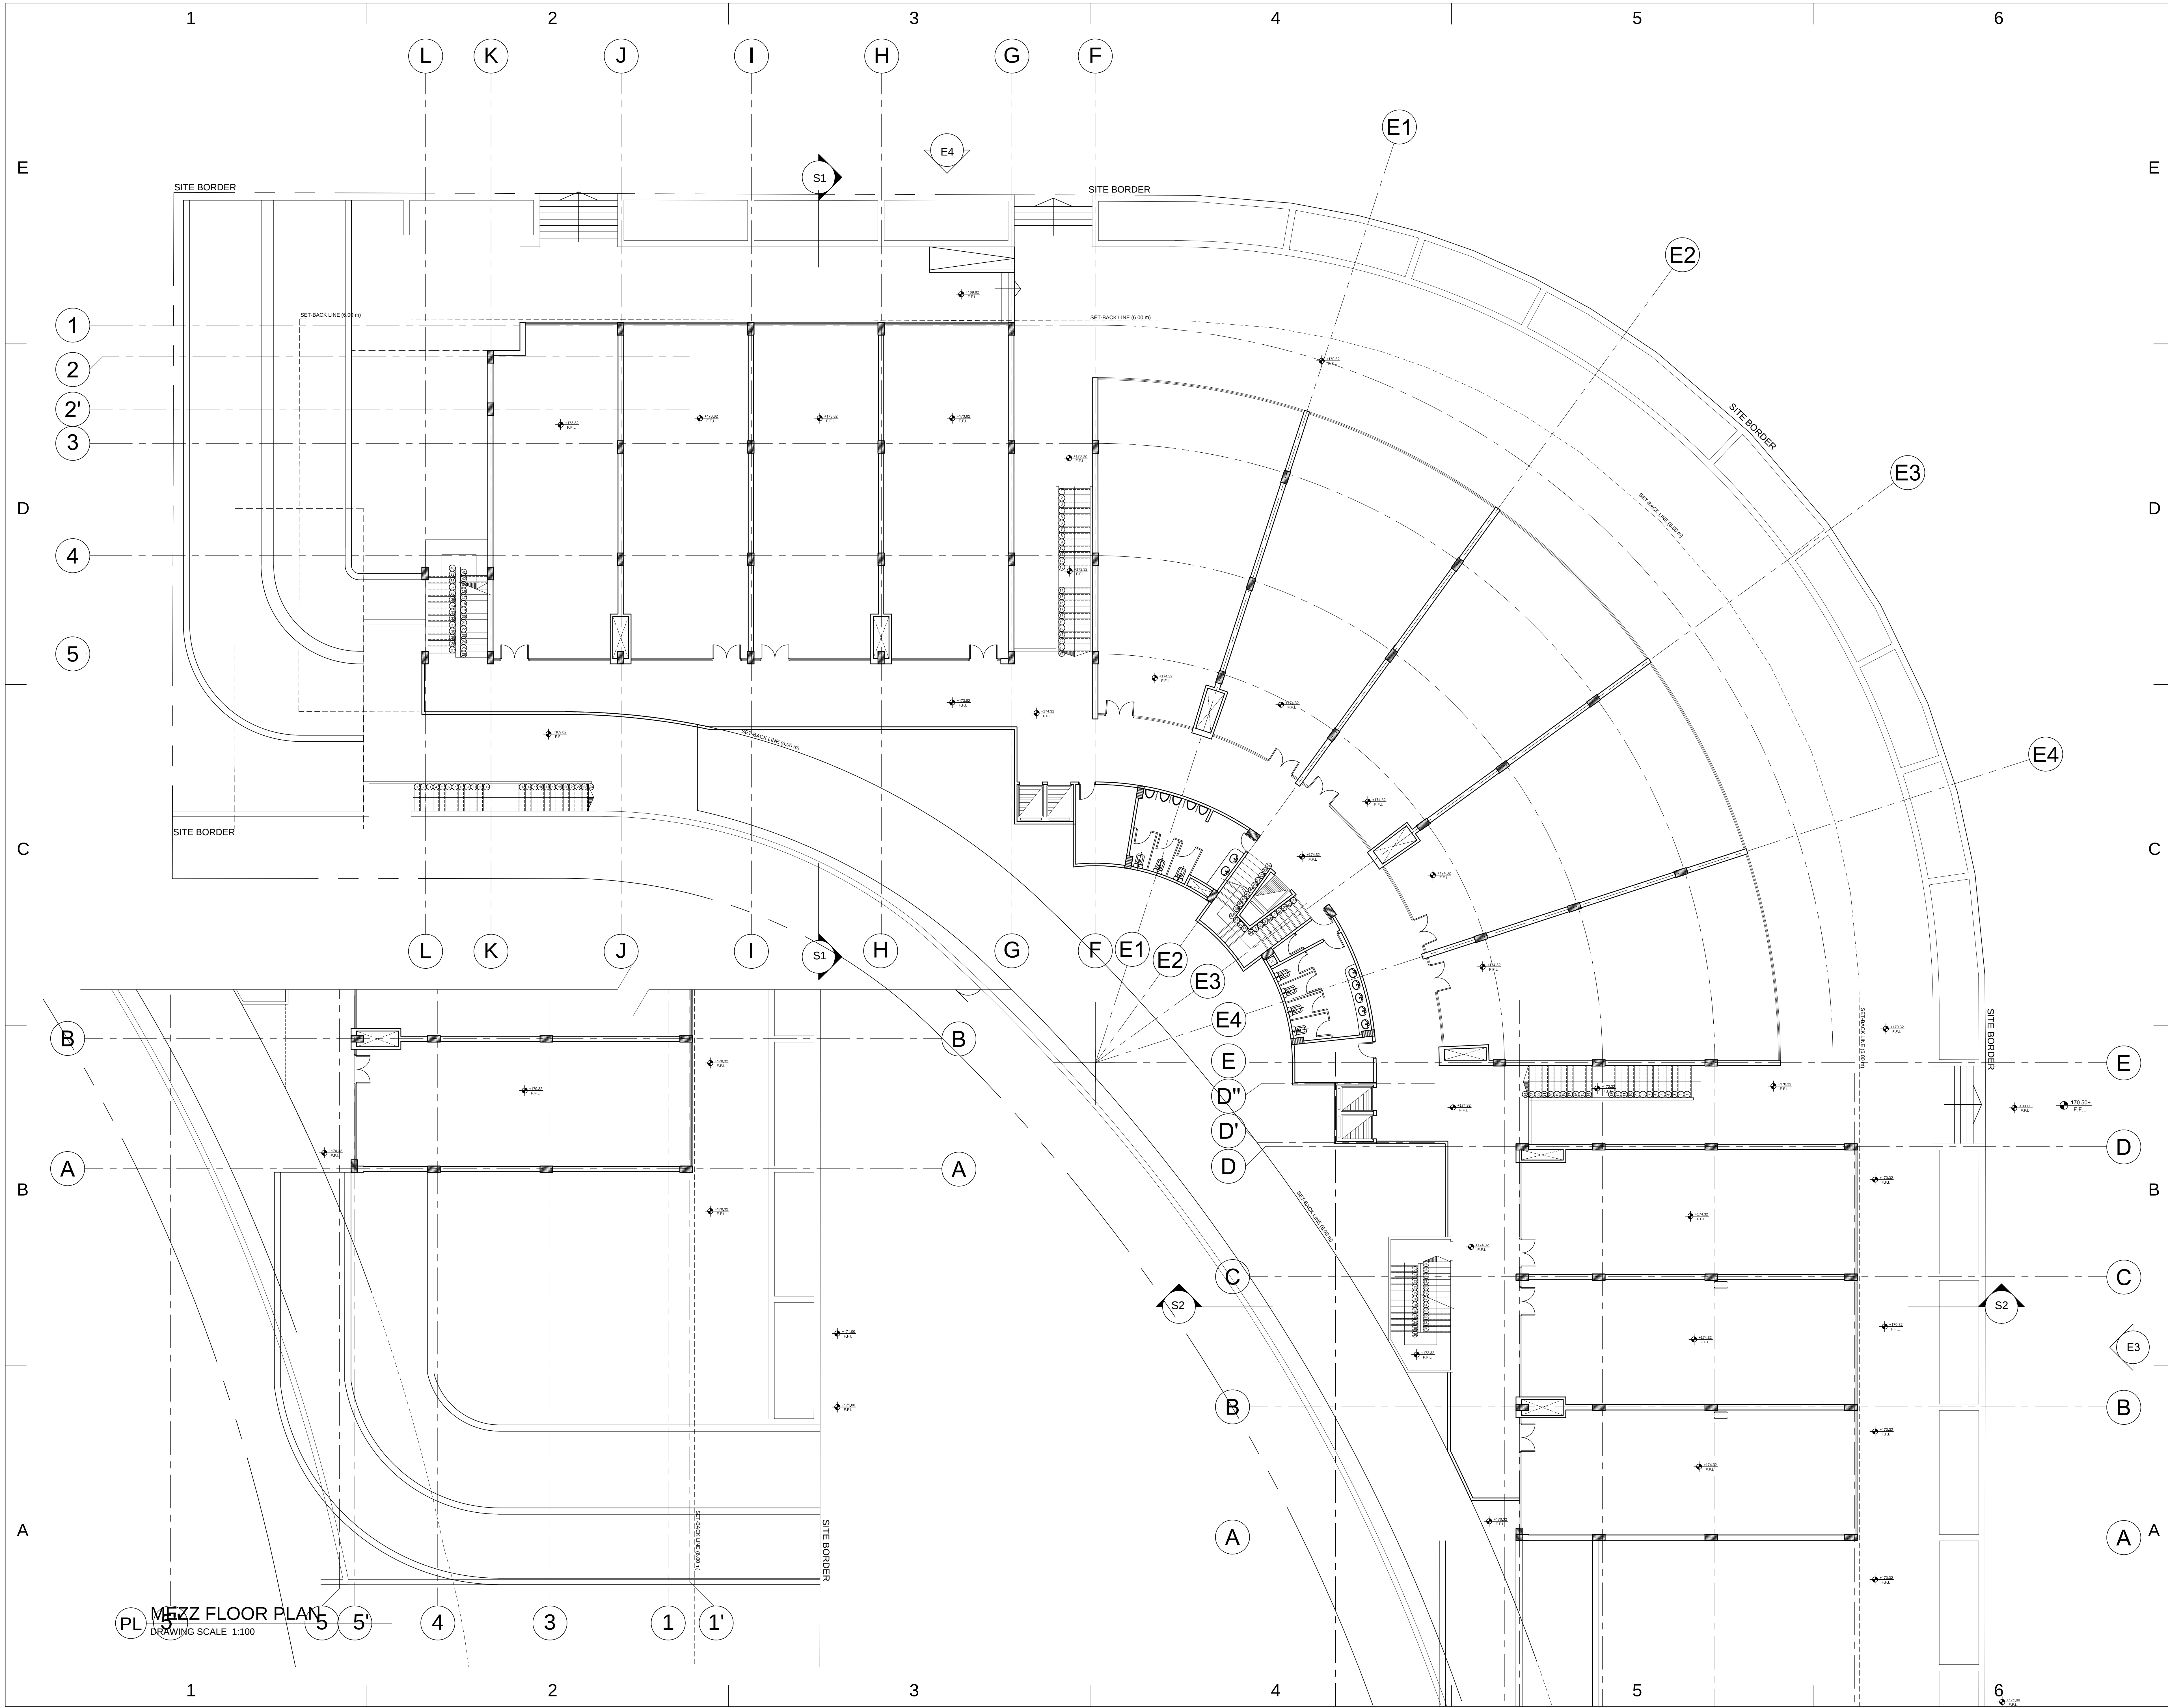

OWNER / PROJECT

ALBAYAN
FOR INVESTMENT

CONSULTANTS

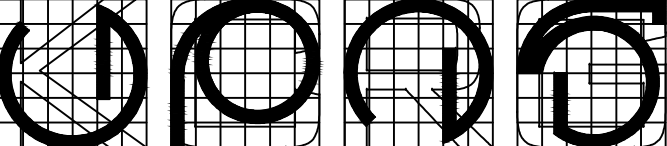

KAMEL CONSULTANTS & RESEARCH GROUP
ARCHITECTURE, URBAN DEVELOPMENT, RESEARCH & TECHNOLOGY
CONSULTANT ARCH. & PRINCIPAL:
DR. BASIL AHMED KAMEL
PROFESSOR OF ARCHITECTURE, CAIRO UNIVERSITY
ARCHITECT & PRINCIPAL:
DR. HEBA FAROUK AHMED
ASSISTANT PROF. OF ARCHITECTURE, CAIRO UNIVERSITY
ARCHITECT & ASSOCIATE:
DR. SAMEH M. T. EL FEKI
ASSISTANT PROF. OF ARCHITECTURE, MSA UNIVERSITY
PROJECT TEAM
ARCH. HUSSAM MAGDY
ARCH. AKRAM YOUSSEF
ARCH. ISLAM MAGDY
PROJECT MANAGER /
COORDINATOR

STRUCTURE CONSULTANT




ELMANSOURY BUILDING ENGINEERING GROUP
STRUCTURE CONSULTANT
1000 EL DOKKI, CAIRO, EGYPT
TEL: 0111 555 5555
WWW.ELMANSOURYEGYPT.COM

ELECTRO MECHANICAL CONSULTANT

KEY PLAN

NORTH DIRECTION

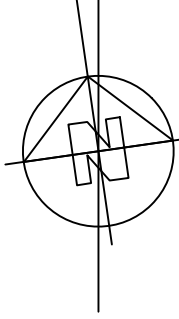

MARK	DATE	DESCRIPTION
04	NOV-2014	FOR REQUEST
03	OCT-2014	FOR REQUEST
02	SEP-2013	FOR PERMIT
01	SEP-2012	FOR PERMIT

ISSUE: 2

PROJECT NO: 09066

CAD DWG FILE:

DRAWN BY: ARCH: ISLAM MAGDY
HAGAR NOURELDEEN

CHECKED BY: ARCH: AHMED ALI

SHEET TITLE

MEZZ. FLOOR PLAN

SCALE 1:100